
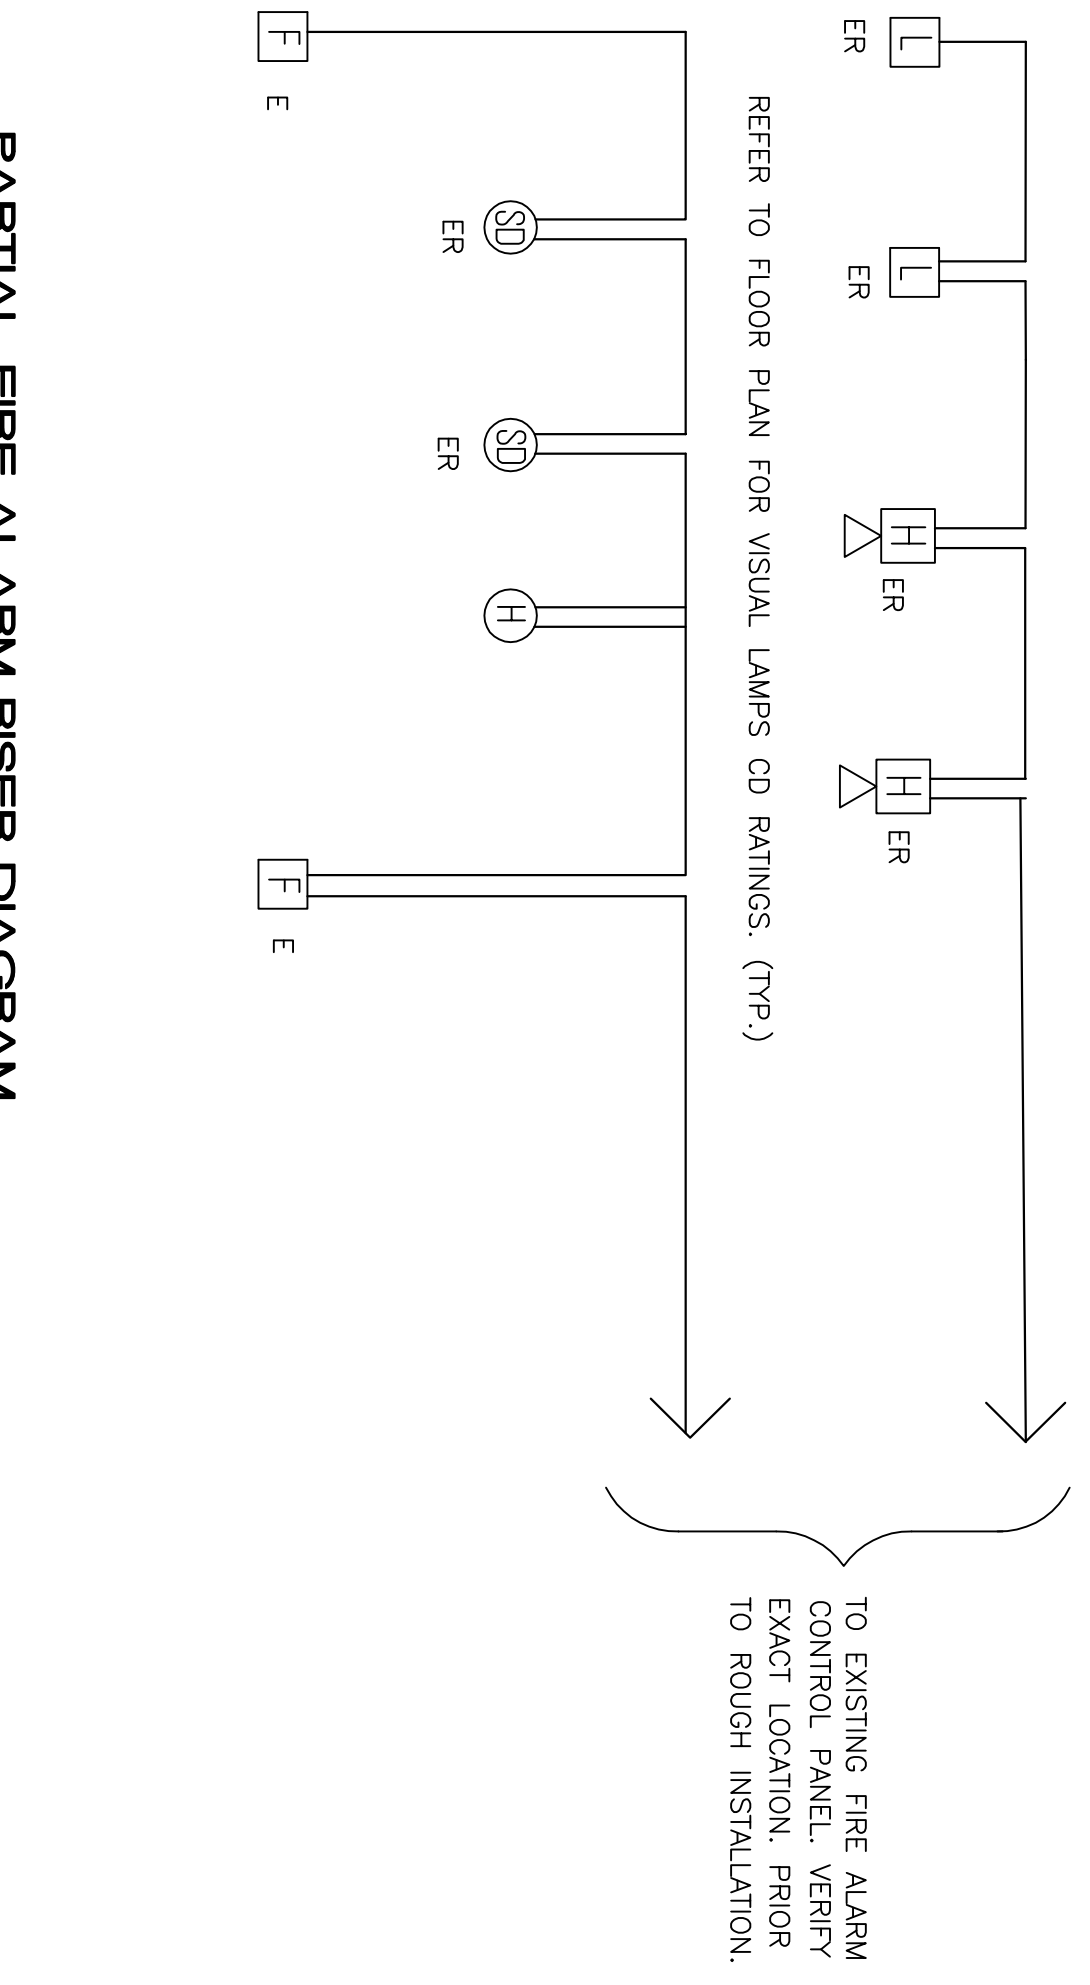
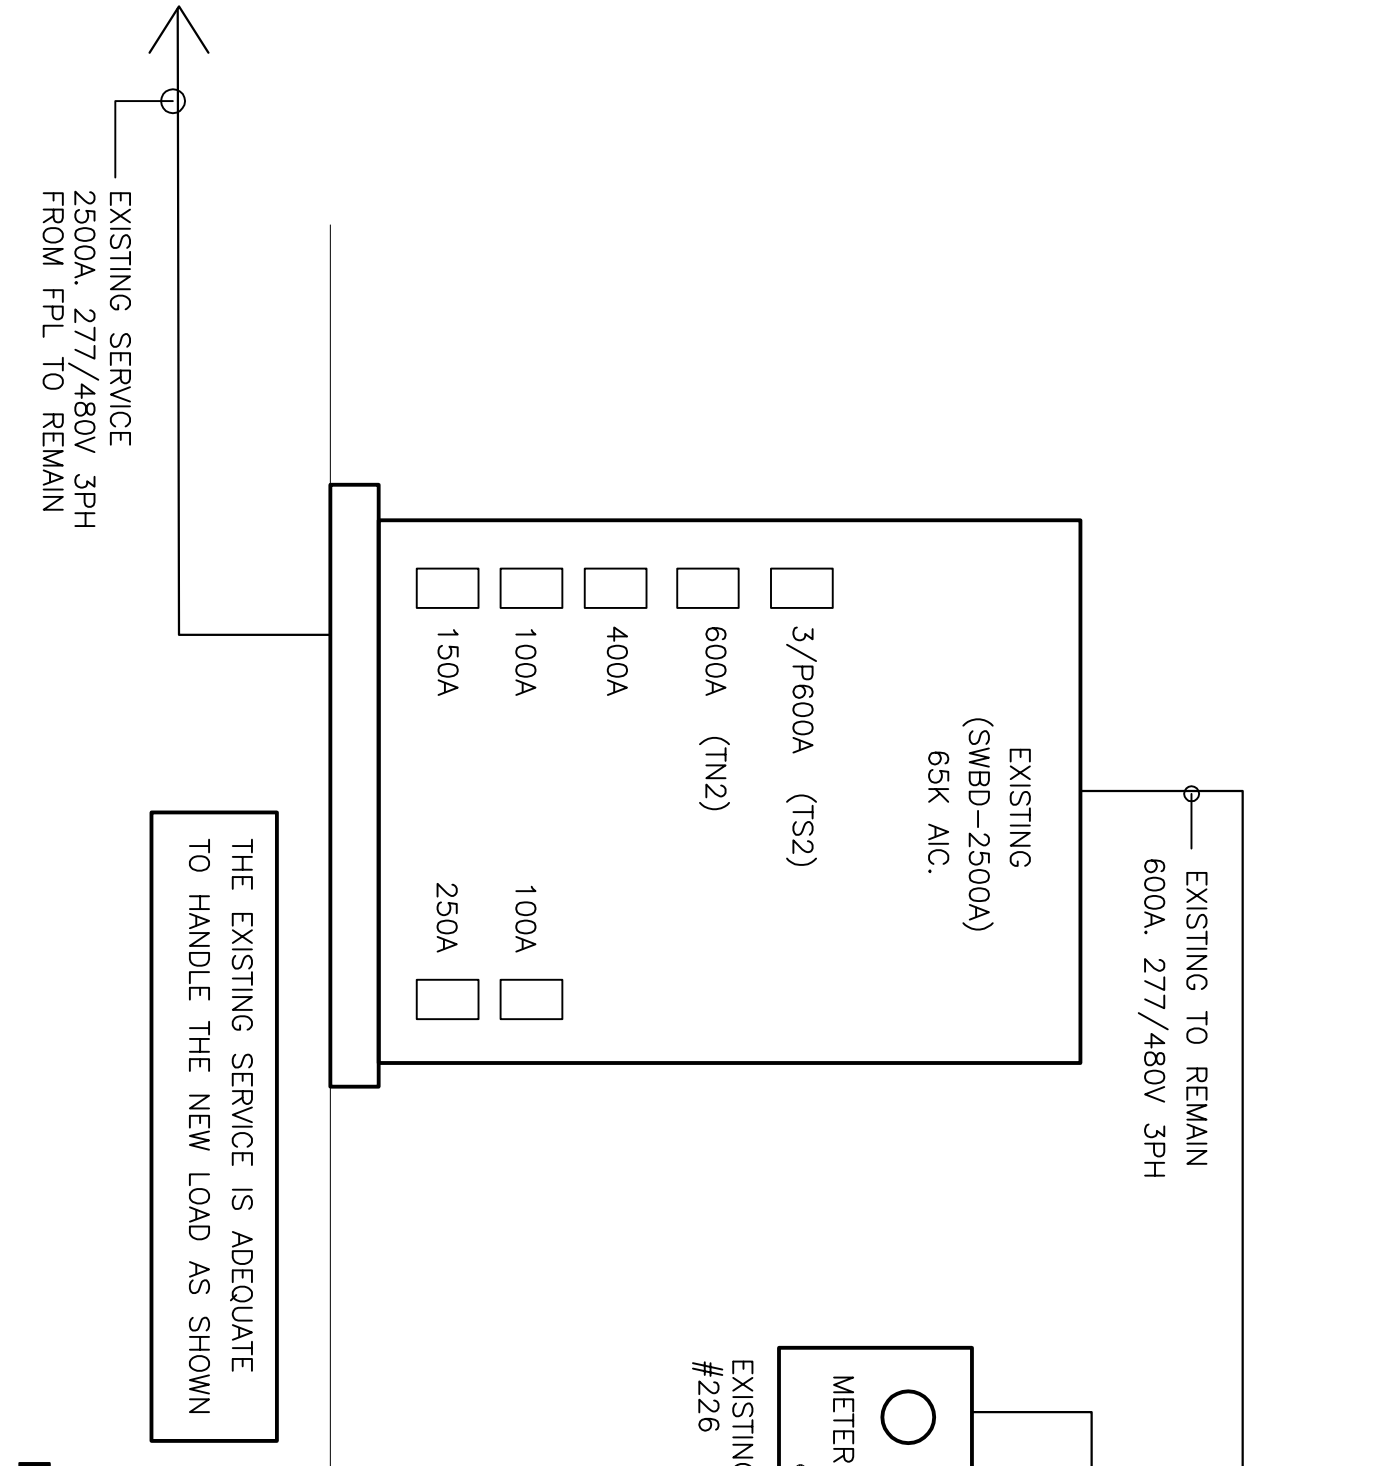


TELEPHONE SYSTEM NOTES

1.) CONTRACTOR SHALL COORDINATE ALL WORK WITH BELLSOUTH PRIOR TO COMMENCEMENT OF WORK.
2.) CONTRACTOR SHALL FURNISH AND INSTALL EMPTY CONDUIT TELEPHONE SYSTEM WITH PULL STRINGS, ALL TELEPHONE BOXES, TEL PLATES AND ALL OTHER NECESSARY ELEMENTS AS SHOWN ON DRAWINGS.

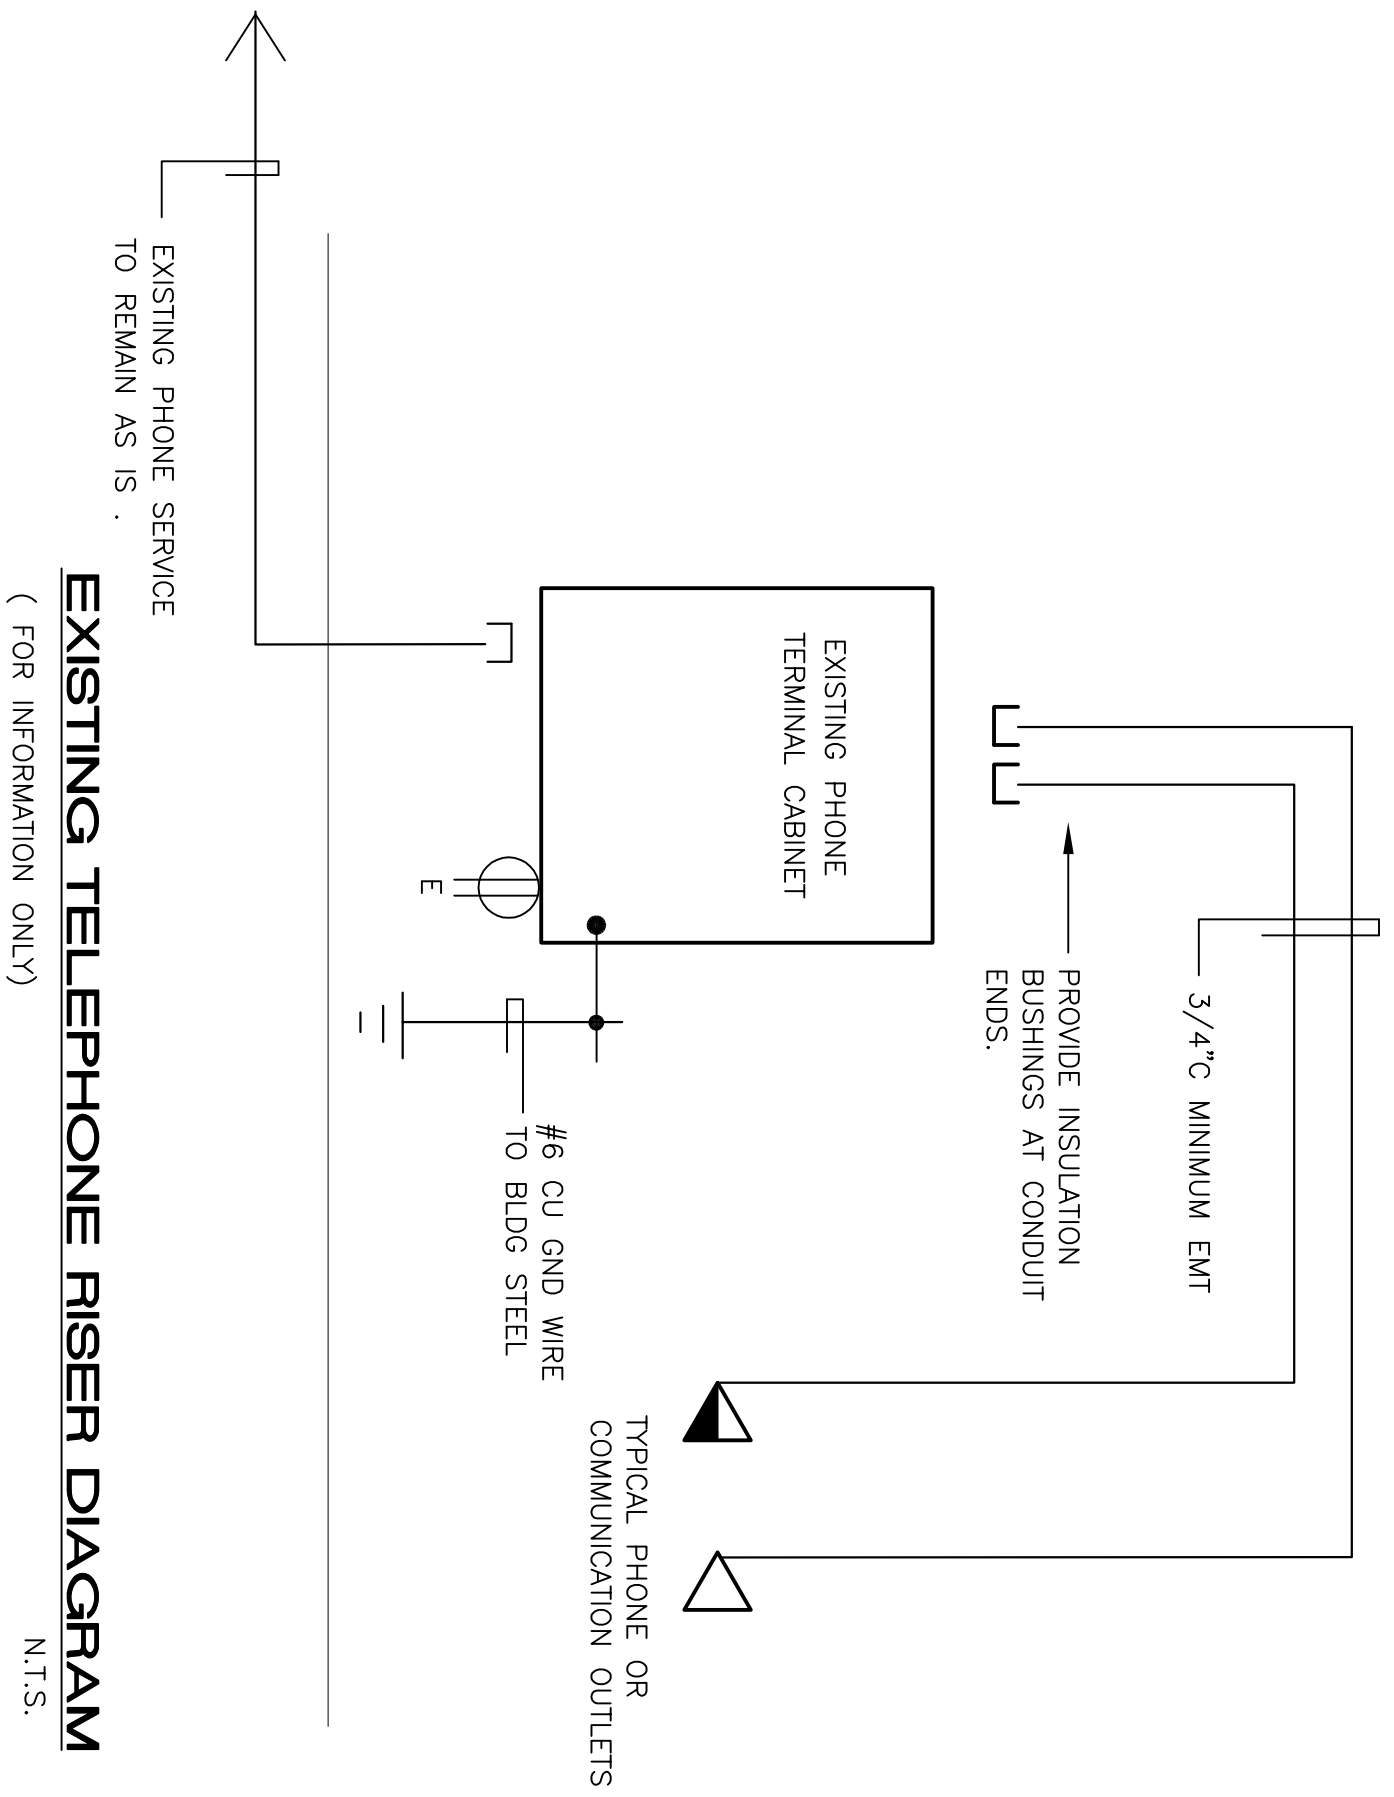


POWER RISER - LEGEND

- 1) ALL ELECTRICAL EQUIPMENT INDICATED BY A DASHED LINE IS EXISTING TO REMAIN
- 2) NEW ELECTRICAL EQUIPMENT INDICATED BY A CONTINUOUS LINE
- 3) ALL SERVICE EQUIPMENT SHALL BE IDENTIFY WITH UNIQUE NAME PLATE INDICATING SERVED
- 4) SEAL ALL EXISTING WALL PENETRATION.

• ELECTRICAL CONTRACTOR TO VERIFY AND PROVIDE EQUIPMENT GROUNDING CONDUCTOR AS PER NEC 250-122

PARTIAL FIRE ALARM RISER DIAGRAM
N.T.S.
(FOR INFORMATION ONLY)

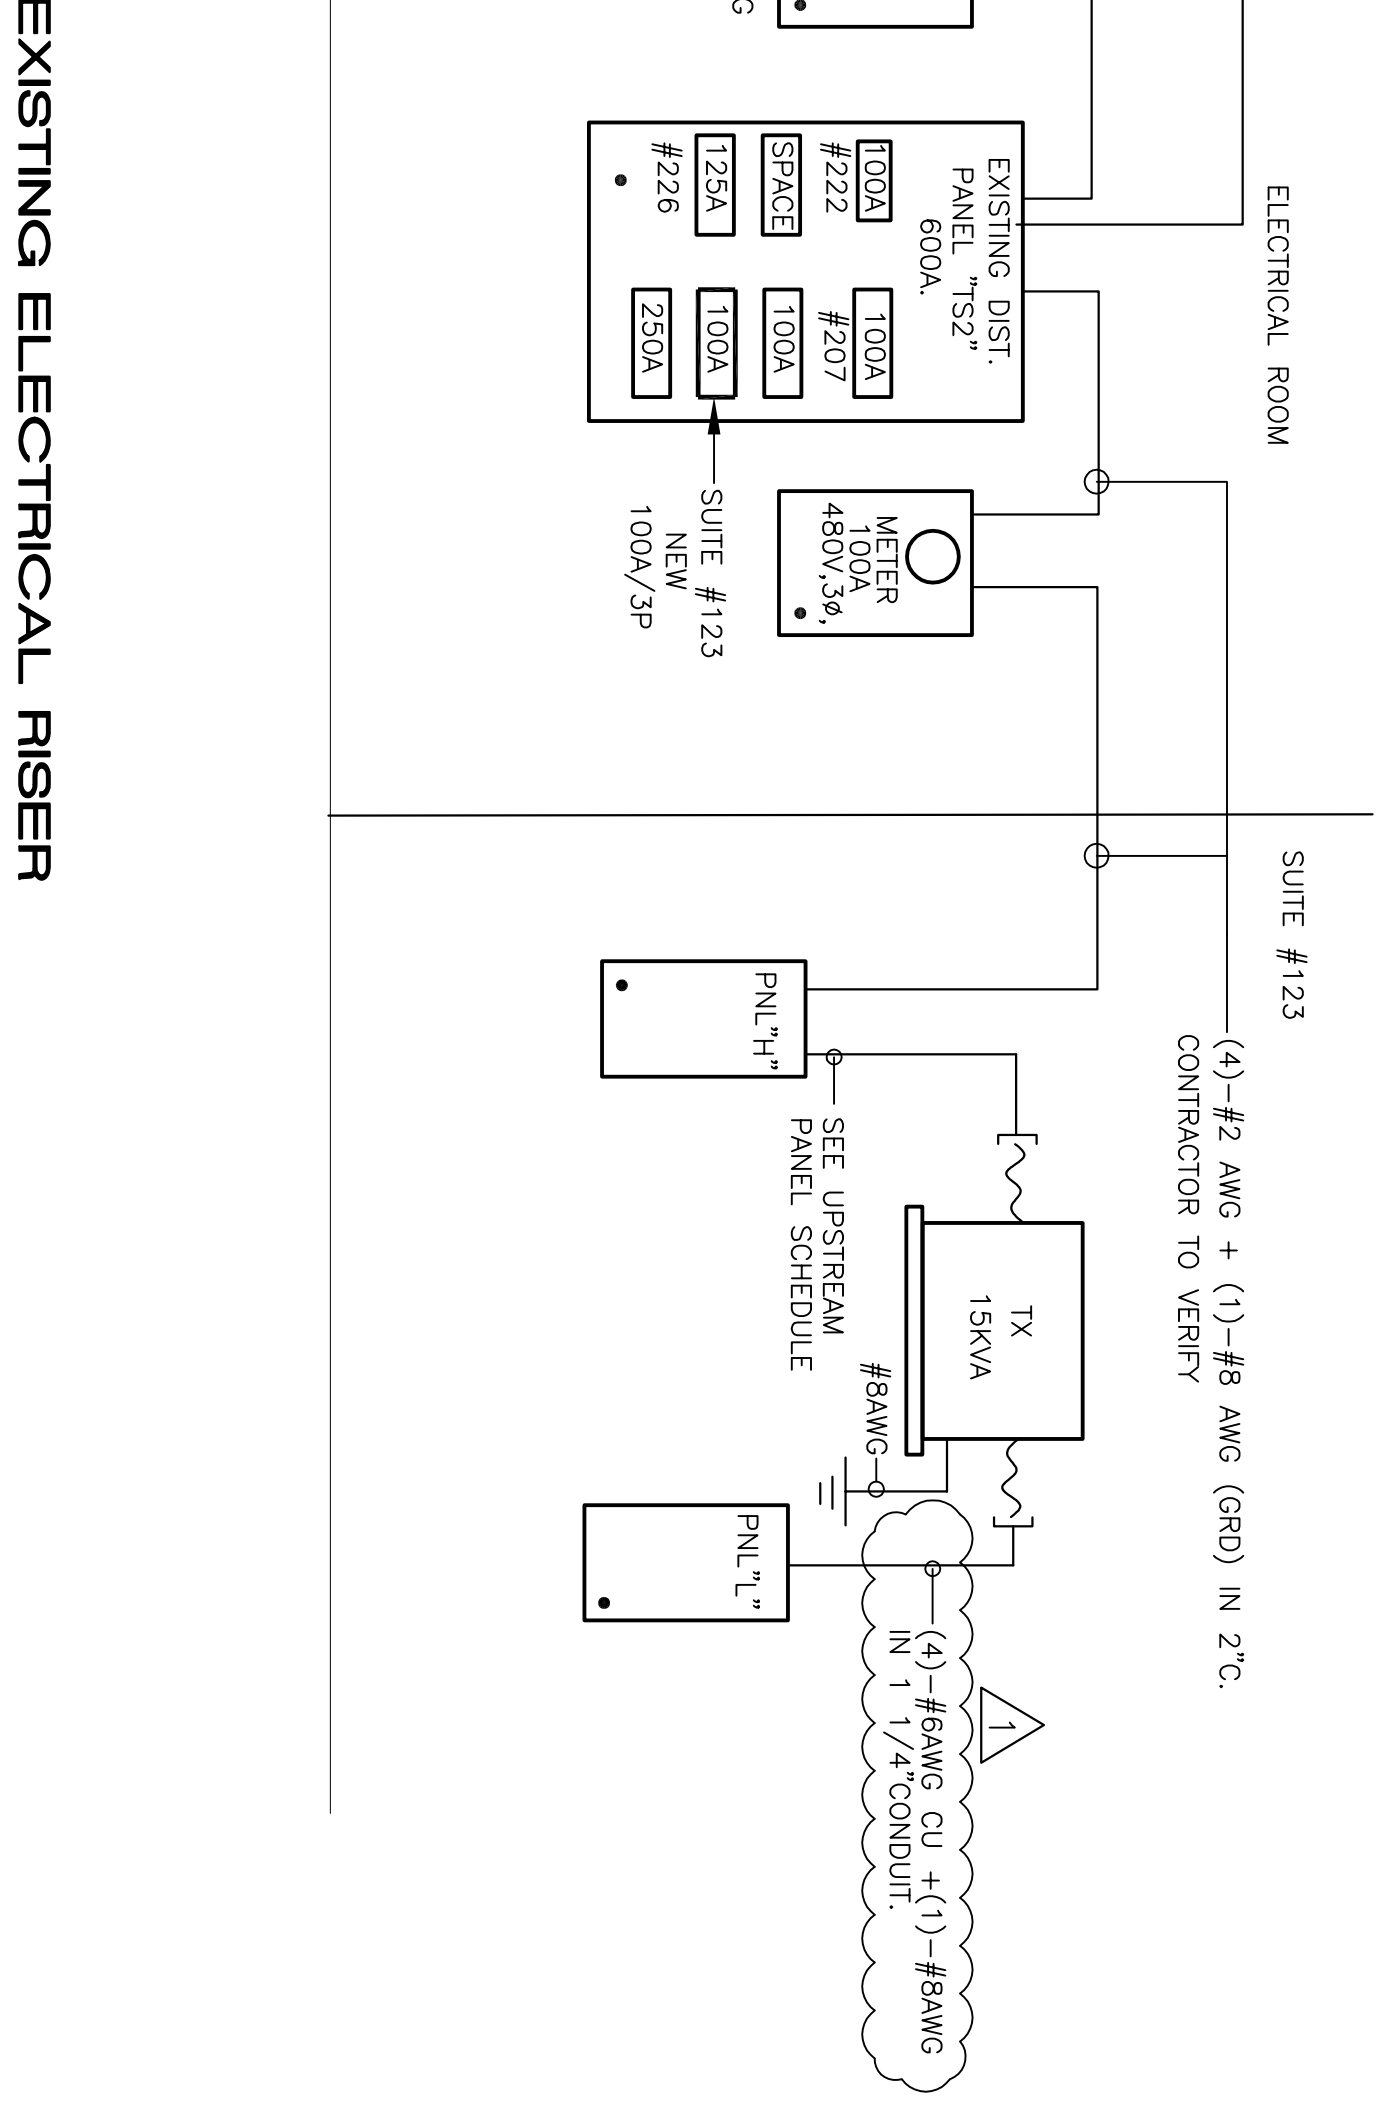

revisions

NO.	DATE	BY
1	09/28/09	T.N.

drawn by: V.P./C.T./S.M.
checked by: T.N.
date: 9/22/09
consultants

project: 20090101